
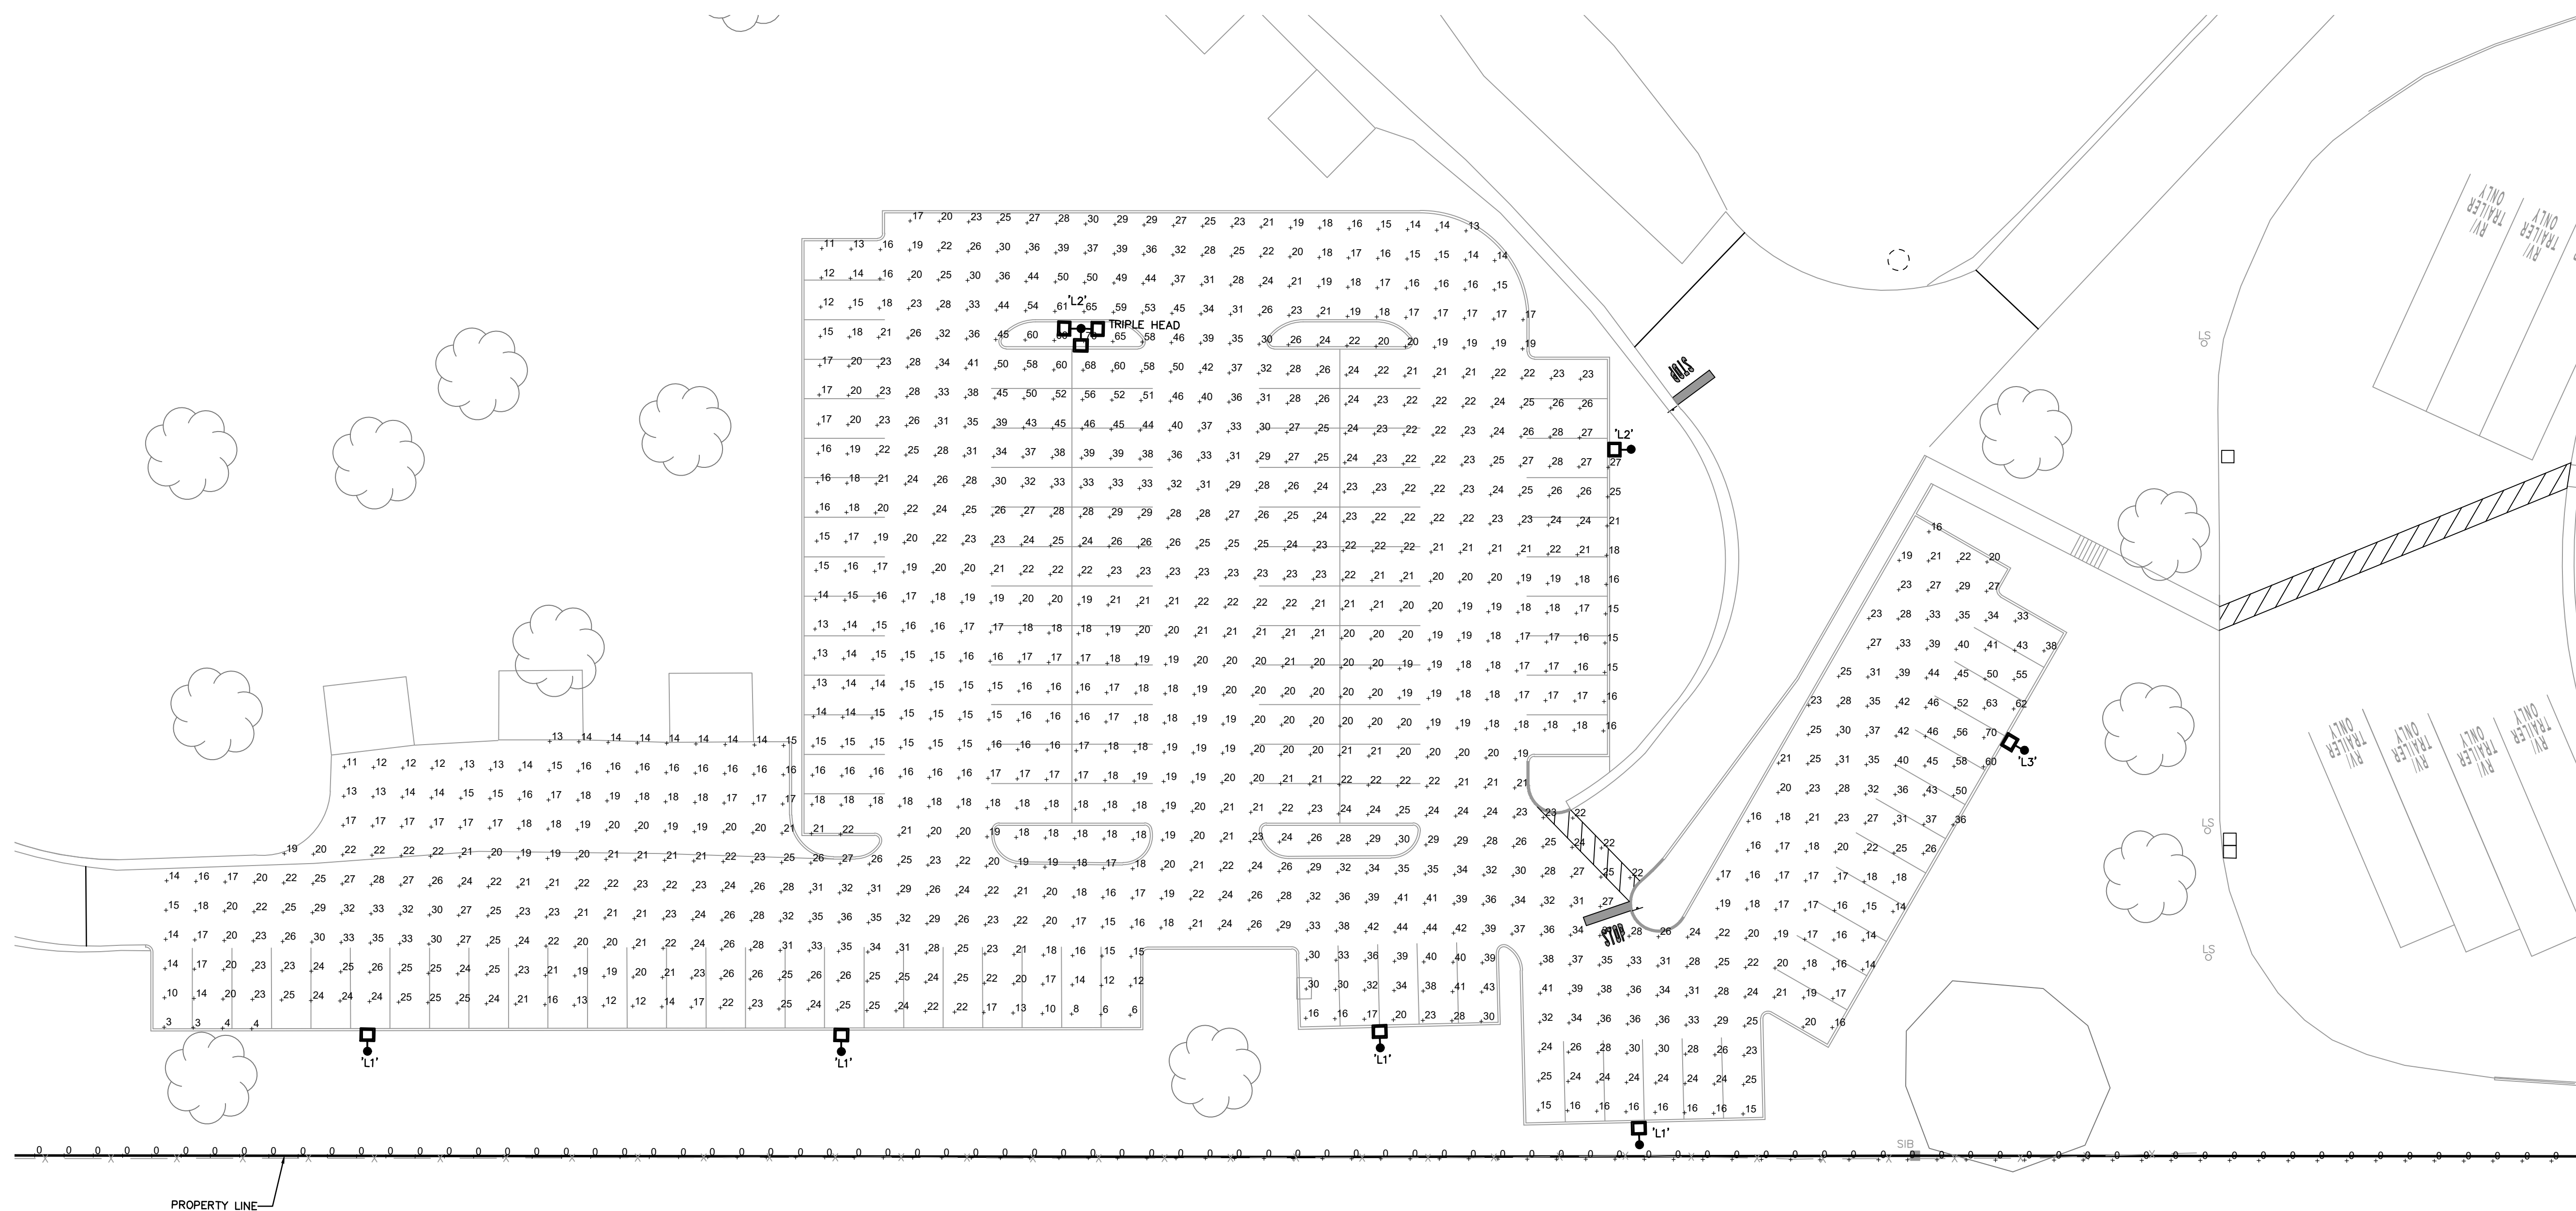


LEGEND


HANDWELL. CONCRETE, 18" DIAMETER, SIMILAR TO
USI#E-32 COMPLETE WITH COVER.

CALCULATION SUMMARY

PARKING AREA (LUX)
AVERAGE: 24 LUX
AVG/MIN: 8:1

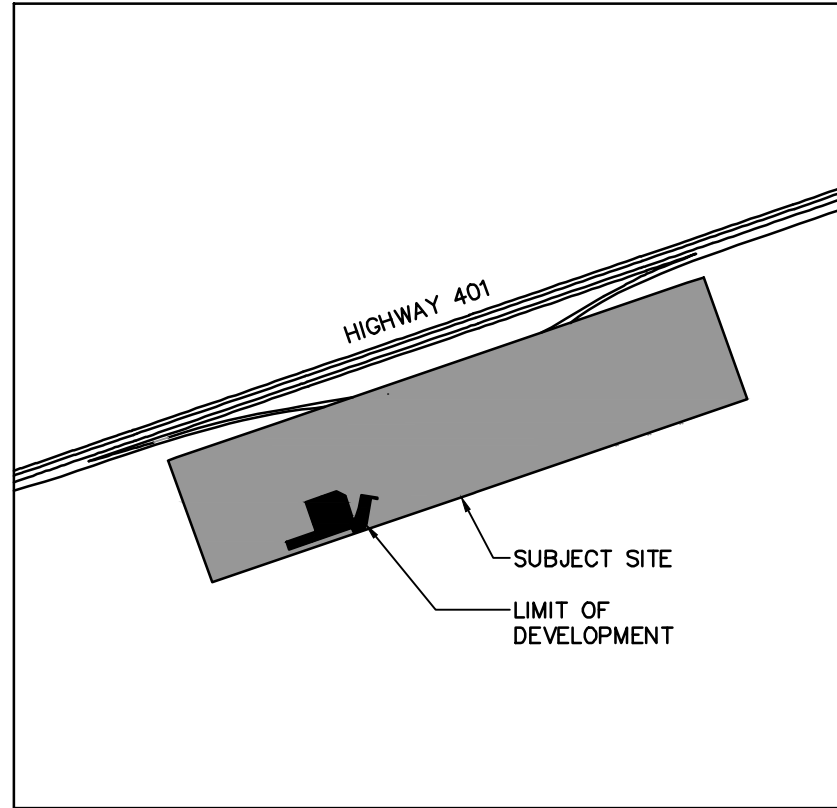

A	ISSUED FOR SPA AMENDMENT AND MTO APPLICATION	JUN 05 2026	P.H.	P.R.
No.	REVISIONS	Date	By	App.

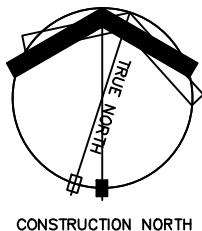

exp Services Inc.
t: +1.905.793.9800 | f: +1.905.793.0641
1595 Clark Boulevard
Brampton, ON L6T 4V1
Canada
www.exp.com



• BUILDINGS • EARTH & ENVIRONMENT • ENERGY •
• INDUSTRIAL • INFRASTRUCTURE • SUSTAINABILITY •

Owner/Client:

ONROUTE
8 PROLOGIS BLVD, UNIT 402
MISSISSAUGA, ON

Location:

ONROUTE PORT HOPE
845 ON-401
PORT HOPE, ON

Title:

PARTIAL SITE LIGHTING PLAN PARKING LOT EXPANSION

CAD File: BRM-22021342-E0-SITE-E01-RA

Designed By: P.H.	Drawn By: P.H.
-------------------	----------------


Scale: 1:250	Date: MAY 2026
--------------	----------------

Case No. :	Project No. : RBM 22021343 E1
------------	-------------------------------

Checked By: P.V

Drawing No.:

E01

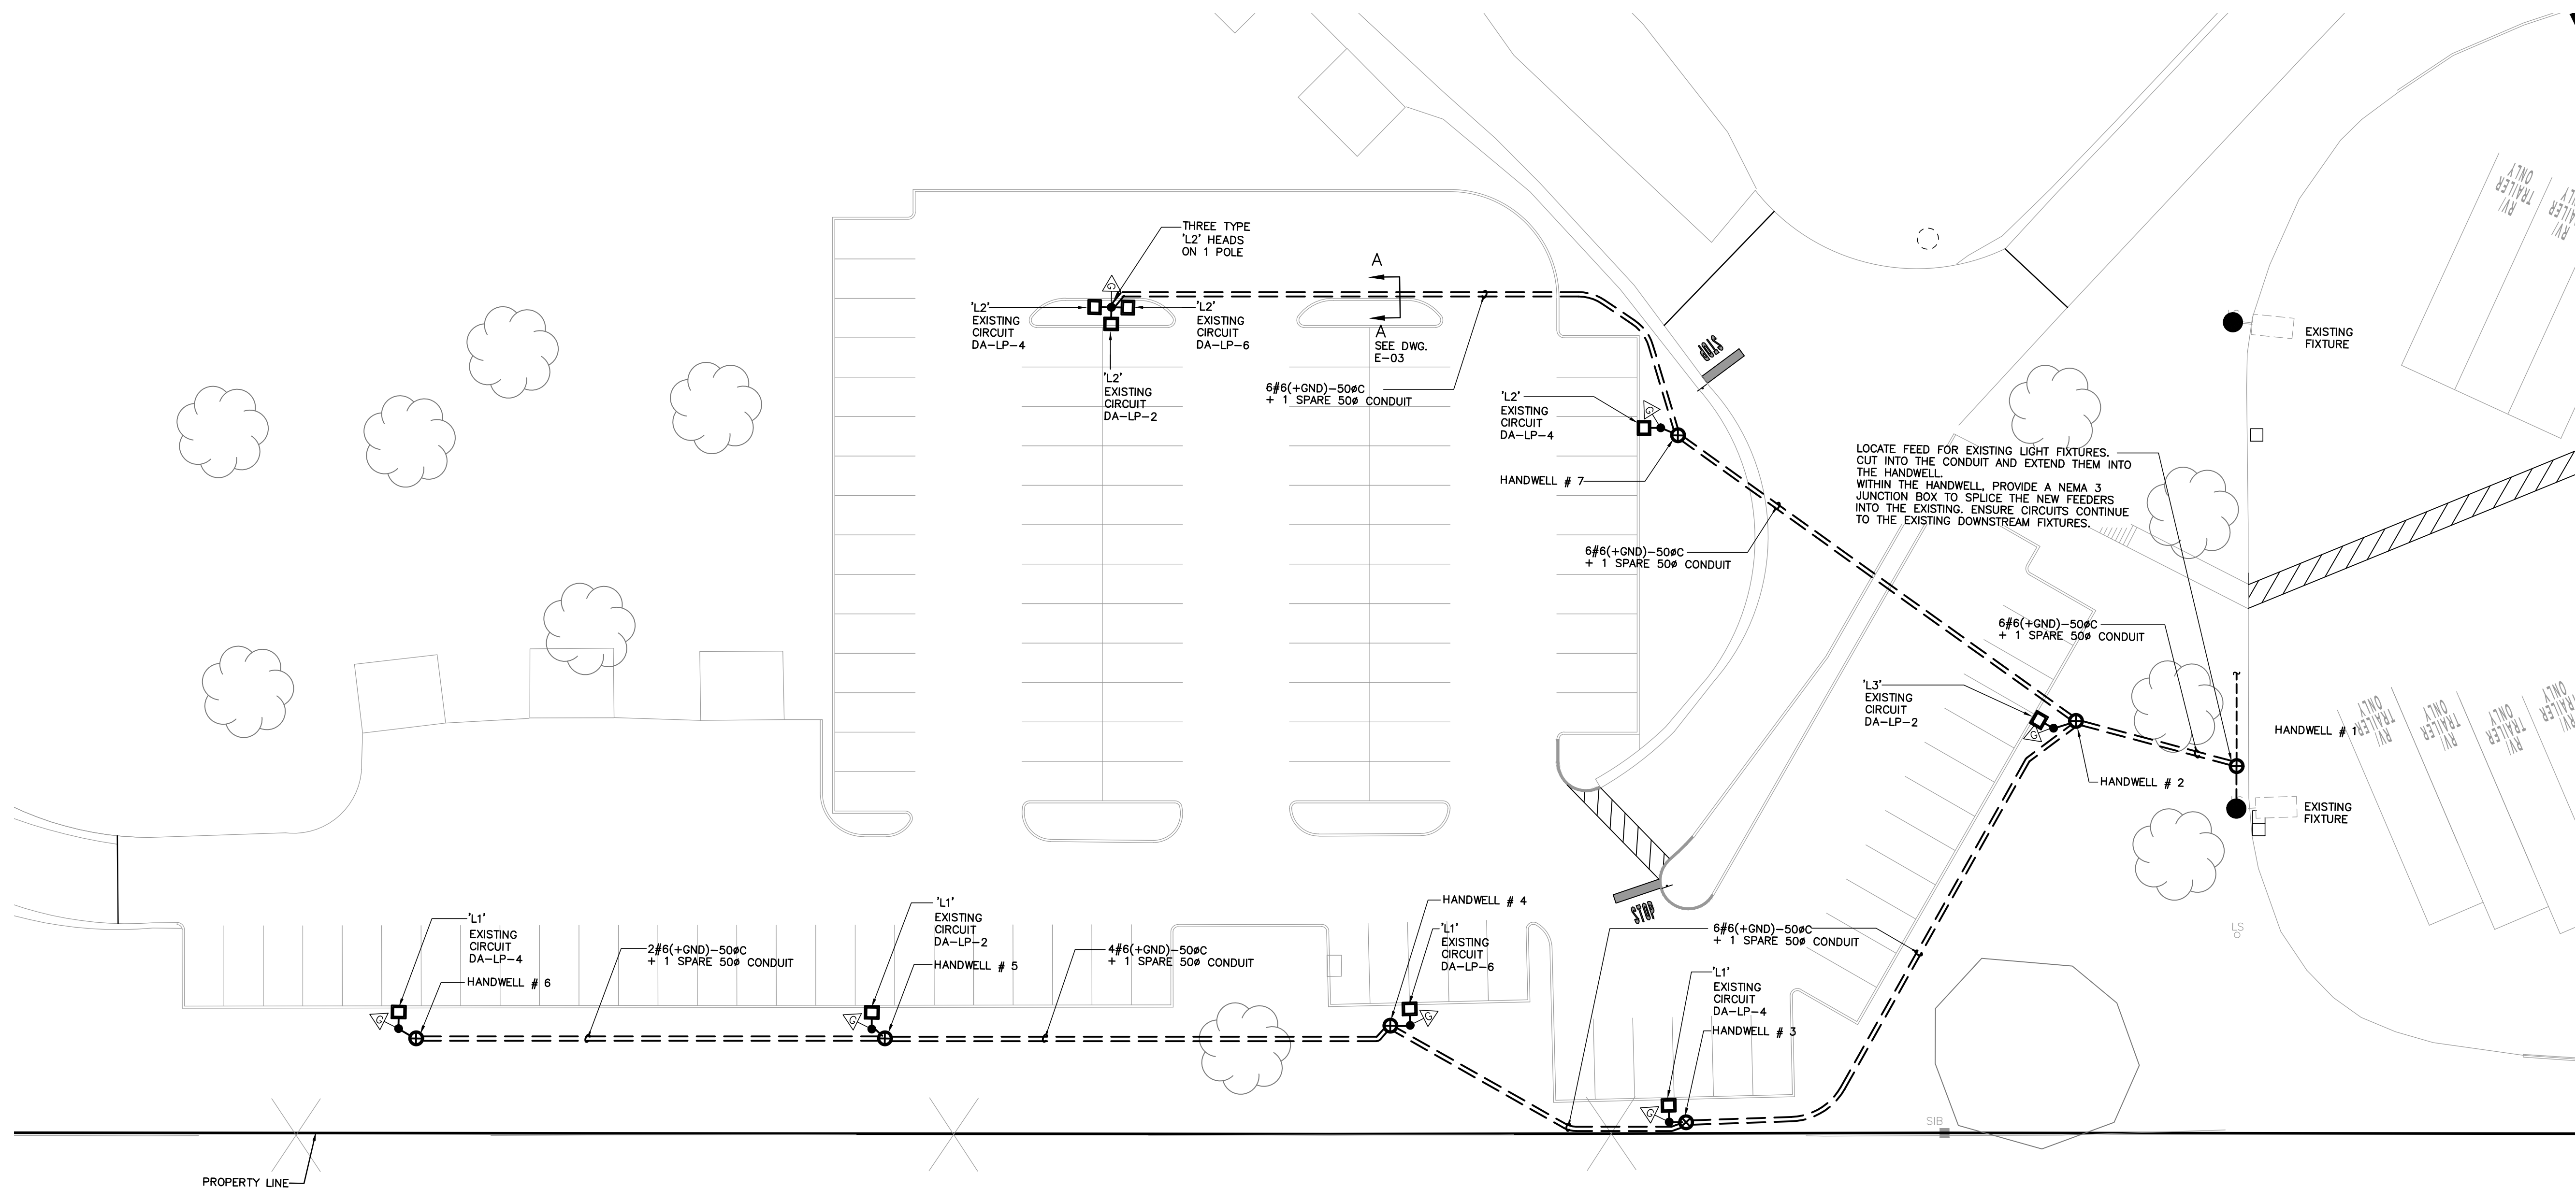


LEGEND

- POLE MOUNTED FIXTURE. SEE FIXTURE SCHEDULE
- NEW BURIED CONDUIT AND WIRE
- GROUND ROD
- HANDWELL. CONCRETE, 18" DIAMETER, SIMILAR TO USI#E-32 COMPLETE WITH COVER.

CALCULATION SUMMARY

PARKING AREA (LUX)
AVERAGE: 24 LUX
AVG/MIN: 8:1

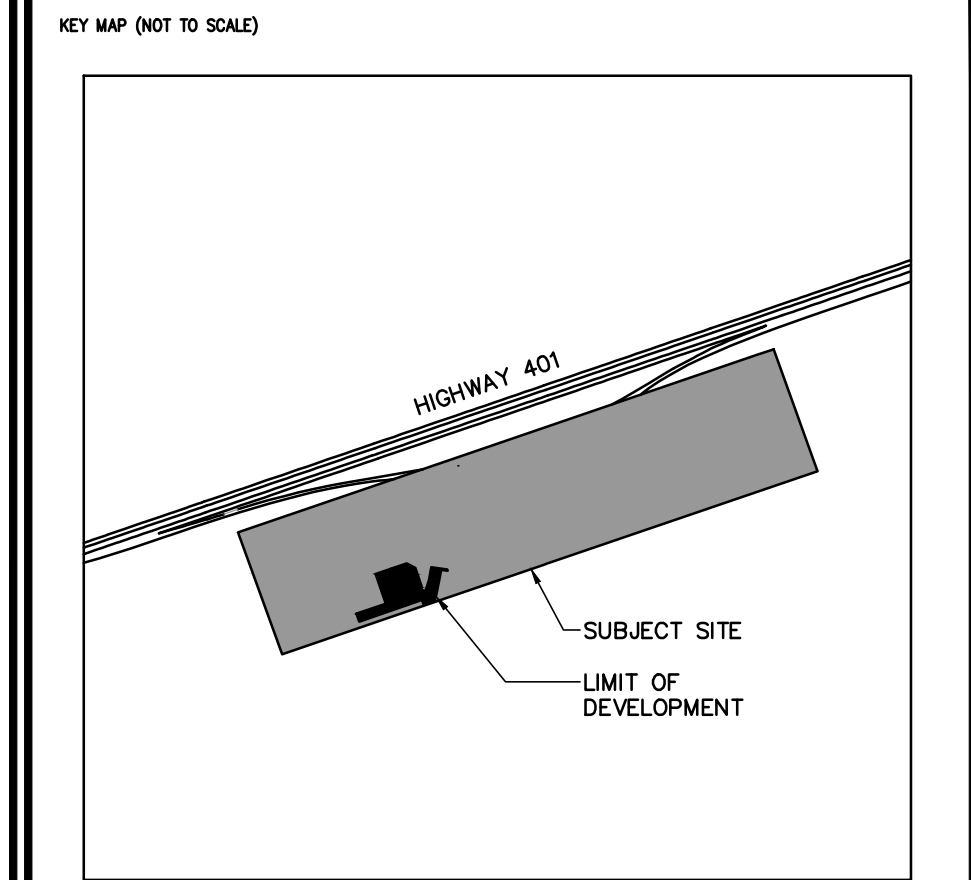

REVISIONS			
No.	Date	By	App.
A	JUN 05 2026	P.H.	P.R.
ISSUED FOR SPA AMENDMENT AND MTO APPLICATION			



exp Services Inc.
t: +1.905.793.9800 | f: +1.905.793.0641
1595 Clark Boulevard
Brampton, ON L6T 4V1
Canada
www.exp.com



- BUILDINGS • EARTH & ENVIRONMENT • ENERGY •
- INDUSTRIAL • INFRASTRUCTURE • SUSTAINABILITY •

Owner/Client:

ONROUTE
8 PROLOGIS BLVD, UNIT 402
MISSISSAUGA, ON

Location:

ONROUTE PORT HOPE
845 ON-401
PORT HOPE, ON

Title:

SITE ELECTRICAL PLAN
PARKING LOT EXPANSION

CAD File: BRM-22021342-E0-SITE-E01-RA			
Designed By: P.H.	Drawn By: P.H.	Checked By: P.V.	
Scale: 1:250	Date: MAY 2026	Drawing No.: E02	
Gas Bar No.:	Project No.: BRM-22021342-E1		

